

Austin
St. Louis
Denver
New York
Carrollinas: P.O. Box 1836
108 South Main Street
Suite B
Davidson, NC 28036
phone 704/856-1696
fax 704/856-1637

Project Team:
General Contractor: Heard Ratzliff Construction
114 Fairview Ave.
Charlotte, NC 28203
phone 704/238-2200
fax 704/238-2200

Structural Engineer: Tom Smiley
12025 Forest Home Dr.
Fort Mill, SC 29715
phone 803/542-2247
fax 803/542-2247

Electrical Engineer: Haas Kennedy
212 N. McDowell St.
Charlotte, NC 28204
phone 704/333-8804

Plumbing Engineer: Bob Morrison
1230 West Morehead St.
Charlotte, NC 28208
phone 704/370-2272

Interior Designer: Envi Studio
163 Tabler Road
Mooresville, NC 28117
phone 704/661-2422

Professional Seal:

Project Title:

**Piedmont Community
Charter School**

Gastonia, NC

RENOVATIONS TO:


E. Second Street

This drawing and details on it, as an instrument of service, is the property of the architect and may be used for the specific project and shall not be loaned, copied or reproduced without the consent of the architect.

No.	Revision	Description	Date

Sheet Title:

Project Number: 21067
Drawn By: _____
Issue Date: 7.18.01
Sheet Number: **A2.6**

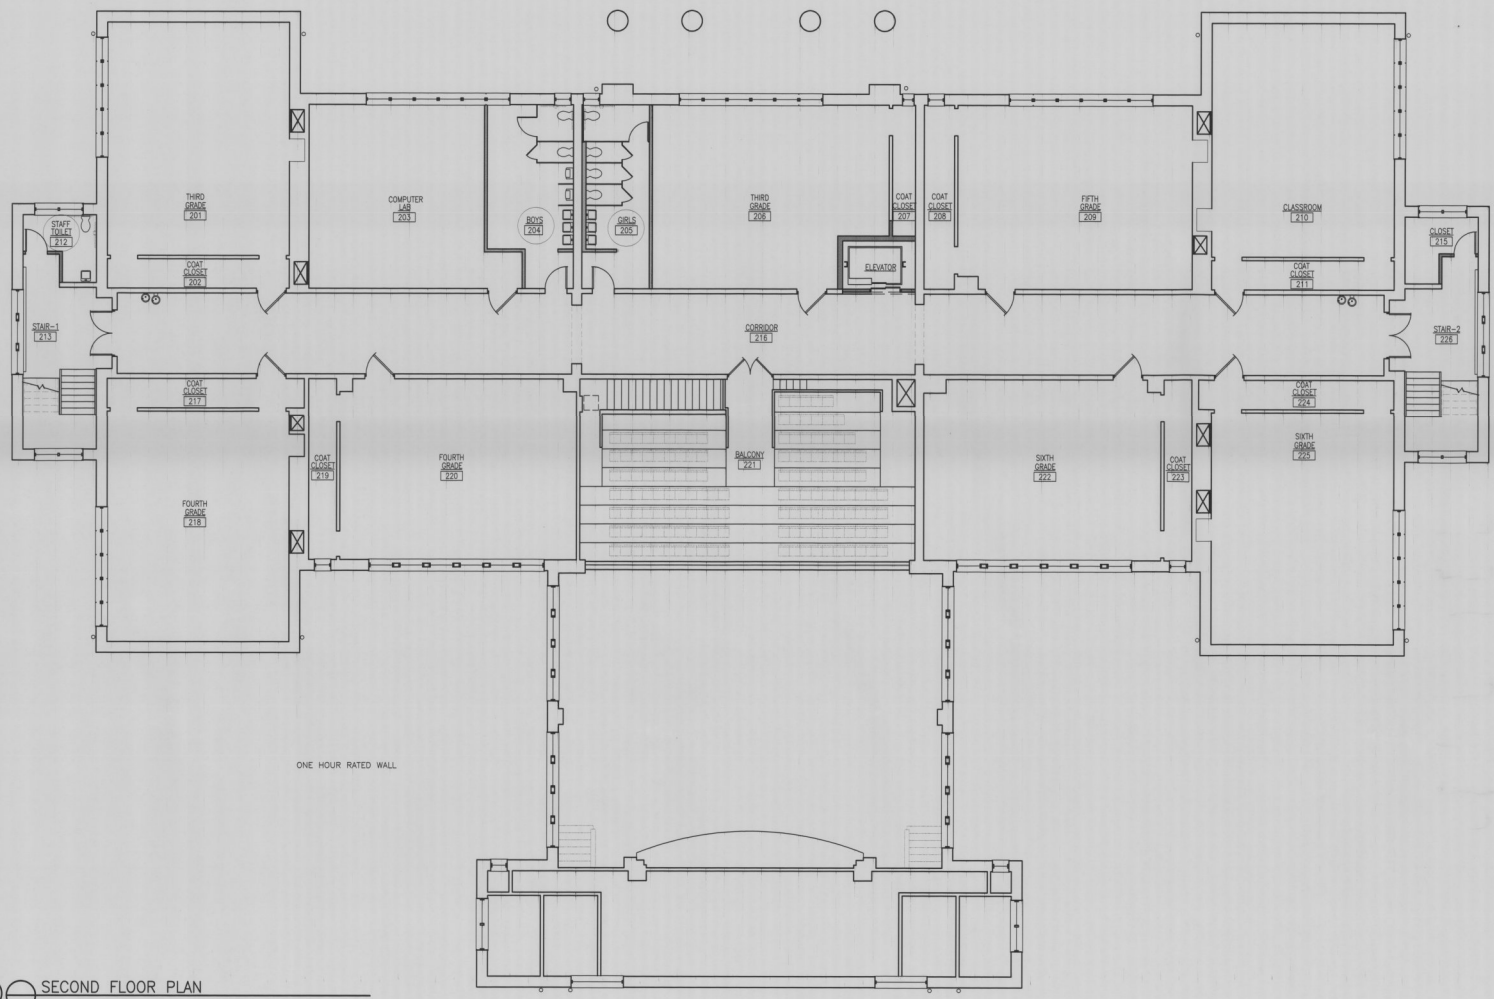

SECOND FLOOR PLAN